

STN No	EASTINGS	NORTHINGS	HEIGHT	TYPE
01	412840.999	93974.164	10.084	Nail
02	412853.981	94009.271	10.290	Nail
03	412901.394	94000.376	10.933	Flag
04	412867.716	93936.107	10.942	Flag
05	412816.892	93950.742	10.580	Nail

LEGEND

ALDER	ALD	BARBED WIRE FENCE	BWF	BOLLARD	B
ASH	ASH	CONCRETE FENCE	CF	BELOW BEACON	BB
ASPEN	ASP	CLOSE BOARD FENCE	CBF	BRITISH TELECOM BOX	BTB
BEECH	BOX	CHAIN LINK FENCE	CLF	BRITISH TELECOM INSPECTION COVER	BTIC
BOX ELDER	BOX	CHESTNUT PALING	CPF	BUS STOP	BS
CEDAR	CEP	CRASH BARRIER	CRB	CABLE TELEVISION INSPECTION COVER	CTIC
CHERRY	CHY	HANDRAIL	HCL	CABLE TELEVISION BOX	CTB
COTTONWEAVER	COT	IRON RAILINGS	IRF	CONTROL BOX	CB
CYPRESS	CYP	INTERLOCKED FENCE	INF	SAWING ROD	SR
ELM	ELM	IRON MESH FENCE	IMF	ELECTRICITY BURIED CABLE MARKER	ELBC
FIR	FIR	LARCH LAP FENCE	LAF	ELECTRICITY CABLE PIT	ELCP
FRUIT	FRT	MISCELLANEOUS FENCE	Mis F	ELECTRICITY CONTROL BOX	ECB
HAWTHORN	HAW	PALING FENCE	PF	ELECTRICITY Pylon	EPYLN
HAZEL	HZL	RALUADE FENCE	RWF	ELECTRICITY SUPPLY	ES
HOLLY	HLT	POCKET FENCE	PKF	FIRE HYDRANT	FH
HORSE CHESTNUT	HCH	POST AND CHAIN FENCE	PCF	FLAG STAMP	FS
HORNBEAM	HMB	POST AND RAIL FENCE	PRF	FLOWERBED	FB
LABURNUM	LBN	POST AND WIRE FENCE	PWF	FODTRAP	FT
LARCH	LAR	STOCK WIRE FENCE	SWF	GAS CONTROL BOX	GCB
LAUREL	LUR	WIRE MESH FENCE	WMF	INSPECTION COVER	IC
LIME	LIM	TRELLIS	TLS	LAMP POST	LP
LOCUST	LOC	RETAINING WALL	RWHL	LETTER BOX	LB
LONDON PLANE	LPL	BASEMENT LEVEL	BTL	LITTER BIN	LBIN
MANGROVE	MNG	RED LEVEL	RL	NERE OUTLET	NO
MAPLE	MPL	COVER LEVEL	CL	MANHOLE (FULL OR SURFACE)	MH
MULBERRY	MUL	DAMP PROOF COURSE	DPC	NAME PLATE	NP
OSK	OSK	FLOOR LEVEL	FL	NAME BOARD	NB
PINE	PNE	INVERT LEVEL	IL	CANALIA POST	CP
POPULAR	POP	OUTFALL LEVEL	OL	OVERHEAD CABLE	OC
PRUNUS	PNS	THRESHOLD LEVEL	TL	POST	P
RHODODENDRONS	RHD	RANK WATER PIPE	RWP	RAISED FLOWERBED	RFB
ROWAN	ROW	FOUL WATER	FW	REFLECTOR POST	RP
SILVER BIRCH	SIB	SURFACE WATER	SW	ROAD SIGN	RS
SORBUS	SOR	GULLY	G	RODDING EYE	RE
SPRUCE	SPR	GULLY PIT	GP	SERVICE MARKER POST	SMP
STRAWBERRY	STR	UNABLE TO LIFT	UL	SOIL VENT PIPE	SVP
SWEET CHESTNUT	SCH	OBSTRUCTED	OB	STOP COOK	SC
SYCAMORE	SYC	WATER LEVEL	WL	STOP VALVE	SV
WALNUT	WNT	CONCRETE	Conc	TELEGRAPH POLE	TP
WILLOW	WLW	PAVING SLABS	PS	TELEPHONE CALL BOX	TSCB
YEW	YEW	BRICK PAVING	BP	TRAFFIC LIGHTS	TL
SPECIES UNKNOWN	SFU	STONE SETS	SS	TRAFFIC SIGNAL CONTROL BOX	TSCB
		TACTILE PAVING	Tac	WATER METER	WM
		TARMAC	Tar	WATER TAP	WT
		DRAINAGE CHANNEL	DRC	WATER TROUGH	WT


TREES 3 / 3T or Multi / 12 / Sp 10
(Blue Size) (No of Barks) (Dault Row) (Height) (Spread)
Spreads and heights are indicative only

Notes



Scale Bar 1:250

Topographic survey information provided by Digital Terrain Surveys LLP
Drawing number: DTS111217-4X7 / December 2017

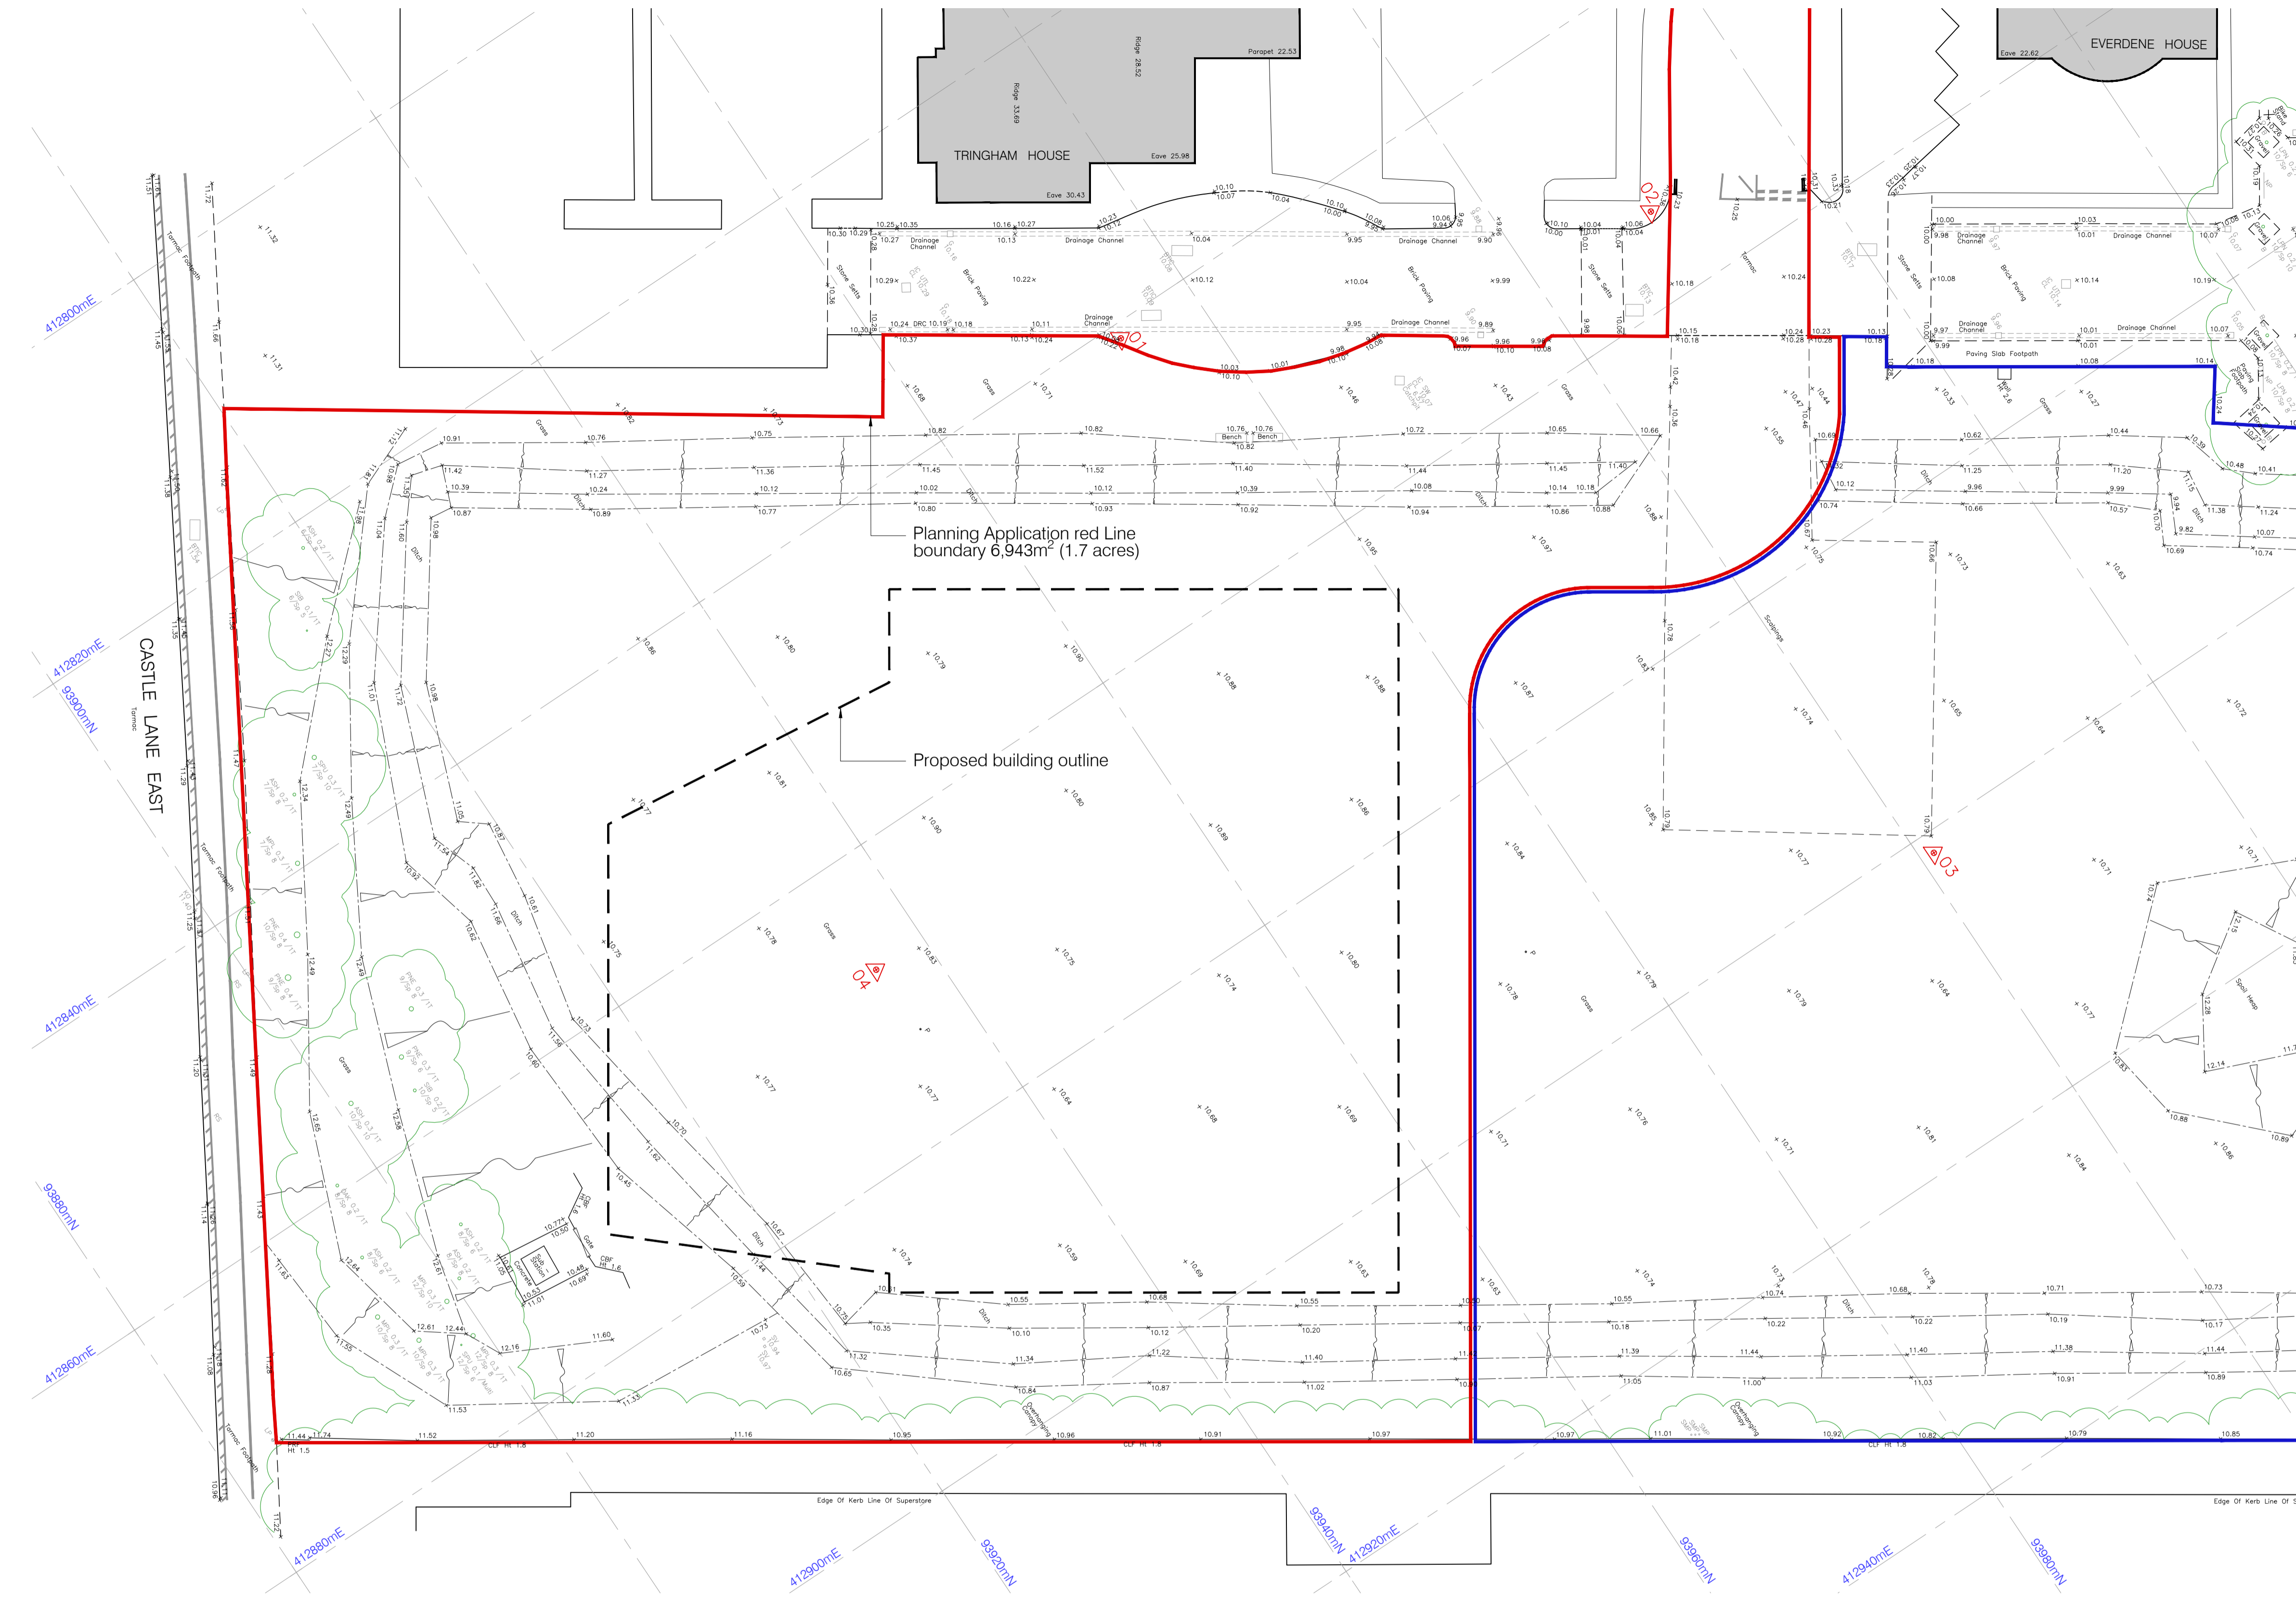

S2	P2	16/01/20	Building footprint updated
PL	P1	17/07/19	PLANNING ISSUE
STATUS	REV	DATE	DESCRIPTION

Scaled dimension are not to be used for construction
Contractor to check all dimensions and report omissions and errors to the Architect

Forum Architecture Ltd Studio S2, Basepoint Andersons Road Southampton, Hampshire SO14 5FE tel: 023 8068 2095		 www.forumarchitecture.co.uk
CLIENT Lok'nStore Limited		
PROJECT New Lok'nStore Facility - Land at Wessex Field Castle Lane East, Bournemouth		
DRAWING TITLE Topographic Site Plan		
DRAWING STATUS PL: PLANNING	DWN BY J.L.	ORIGINATOR No. 18019
	CHK BY T.G.	SCALE 1:250 @A1
PROJECT ORIGINATOR ZONE LEVEL TYPE ROLE CLASSIFICATION NUMBER CLE-FORUM-00-XX-DR-A-XX-P160		REVISION P2