


**NOTES:**

1. The contents of this drawing are copyright.
2. Scaled drawing for Planning purposes only.
3. Contractors must verify all dimensions and report any discrepancies before putting work in hand or making any shop drawings.
4. Lower ground construction/ retaining structure to be structural engineers design.
5. Electrical layout to be agreed with client & added to drawing
6. Drawings to be read in conjunction with specification.

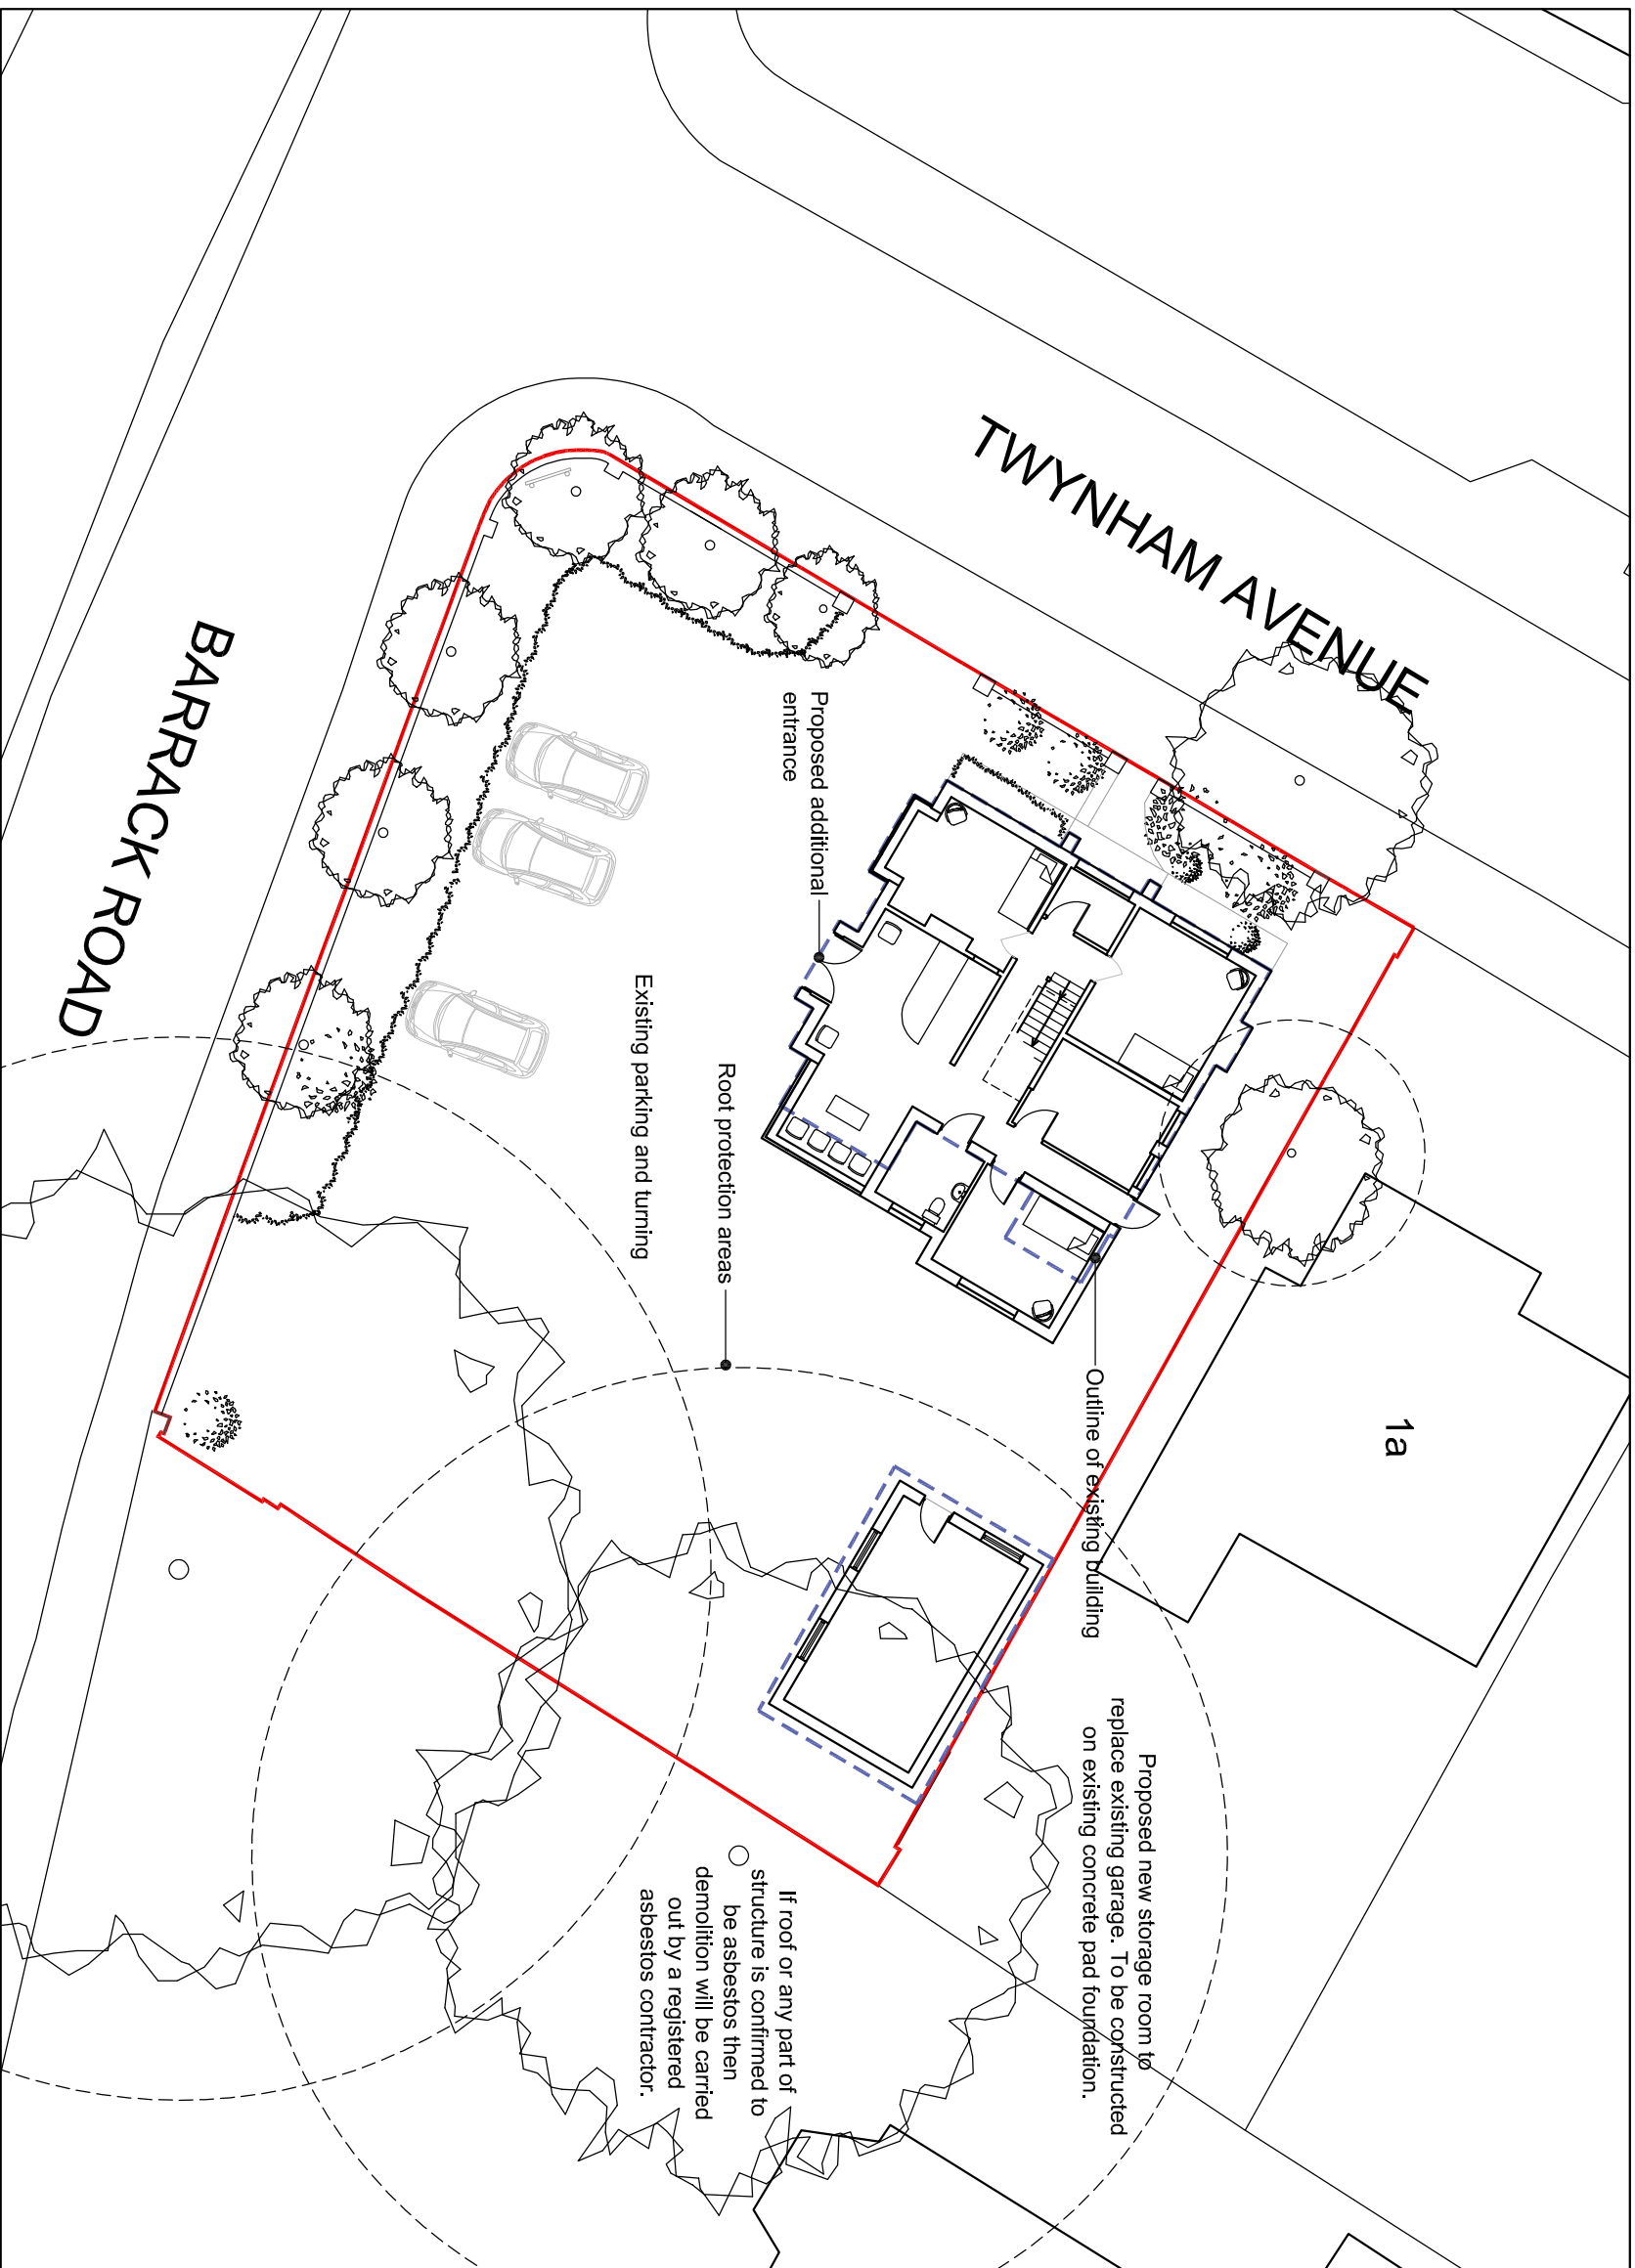

B 27/05/21 Internal layout amended  
A 06/03/21 Asbestos amendment added  
Rev Date Description By  
REVISIONS:  
**PROJECT STAGE:** PLANNING  
**CLIENT:** Life Chiropractic Clinics Ltd

**PROJECT & DRAWING TITLE:**  
Twynham House, Twynham Avenue, Christchurch  
Proposed Site Plan  
**Scale @ A3:1:200** Drawn by: PR  
**Date:** 08/03/2021 **REVISION:**  
**DRAWING NO:** ASP.20.067.002 **REVISION:** B  
**ARCHITECTURE - PLANNING - PROJECT MANAGEMENT - CDM**

4 Stour Road, Christchurch  
Dorset, BH23 3P5  
01202 473242  
www.aspirearchitects.co.uk  
info@aspirearchitects.co.uk  
© Aspire Architects Ltd

