


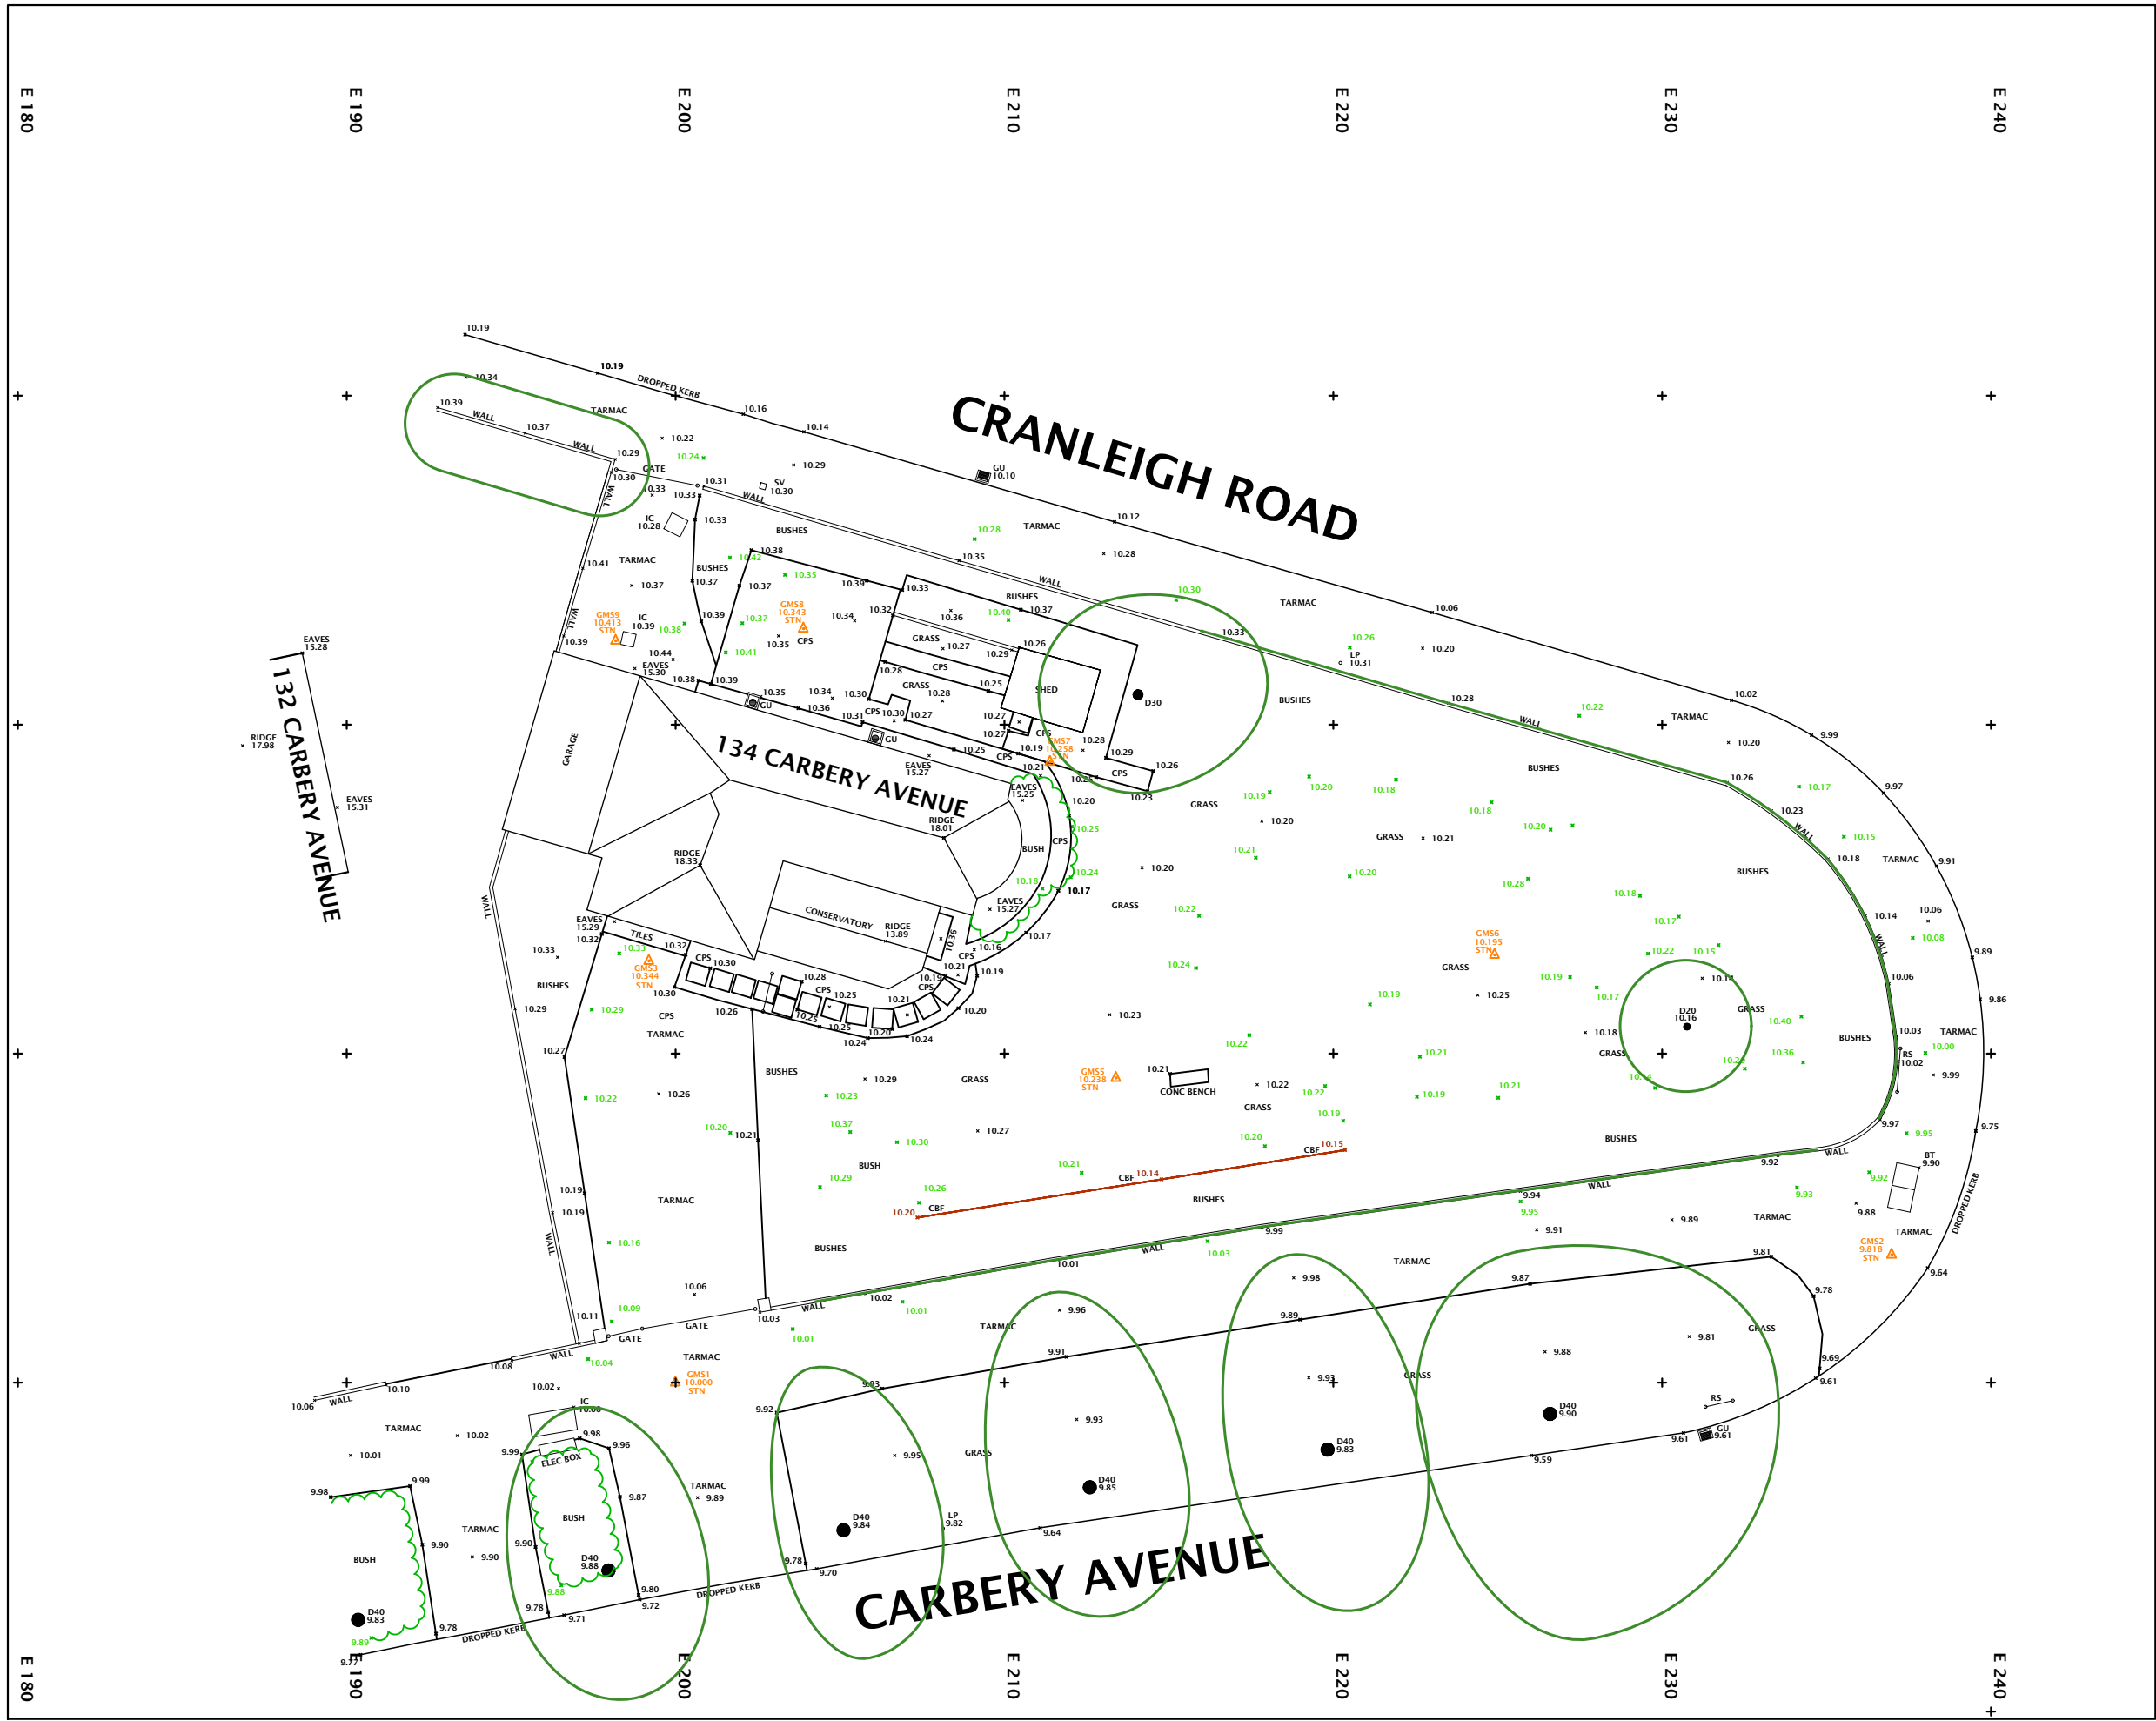

- NOTES:**
1. The contents of this drawing are copyright.
 2. Scaled drawing for Planning purposes only.
 3. Contractors must verify all dimensions and report any discrepancies before putting work in hand or making any shop drawings.
 4. Lower ground construction/ retaining structure to be structural engineers design.
 5. Electrical layouts to be agreed with client & added to drawing
 6. Drawings to be read in conjunction with specification.

REVISIONS:

NO.	DESCRIPTION
1	Issue for Planning

PROJECT STAGE: PLANNING

CLIENT: Fox Homes Ltd

PROJECT & DRAWING TITLE:
134 Carbery Avenue, Bournemouth

Existing Topo

Scale @ A3: 1:200 Date: 11/03/24	Drawn by: CC	
DRAWING No: ASP.23.056.P003		

ARCHITECTURE - PLANNING - PROJECT MANAGEMENT - CDM

74 Sopers Lane
Christchurch,
BH23 1JF
01202 473222

www.aspirearchitects.co.uk
info@aspirearchitects.co.uk

© Aspire Architects Ltd

