


- NOTES:**
1. The contents of this drawing are copyright.
  2. Scaled drawing for Planning purposes only.
  3. Contractors must verify all dimensions and report any discrepancies before putting work in hand or making any shop drawings.
  4. Lower ground construction/ retaining structure to be structural engineers design.
  5. Electrical layouts to be agreed with client & added to drawing
  6. Drawings to be read in conjunction with specification.

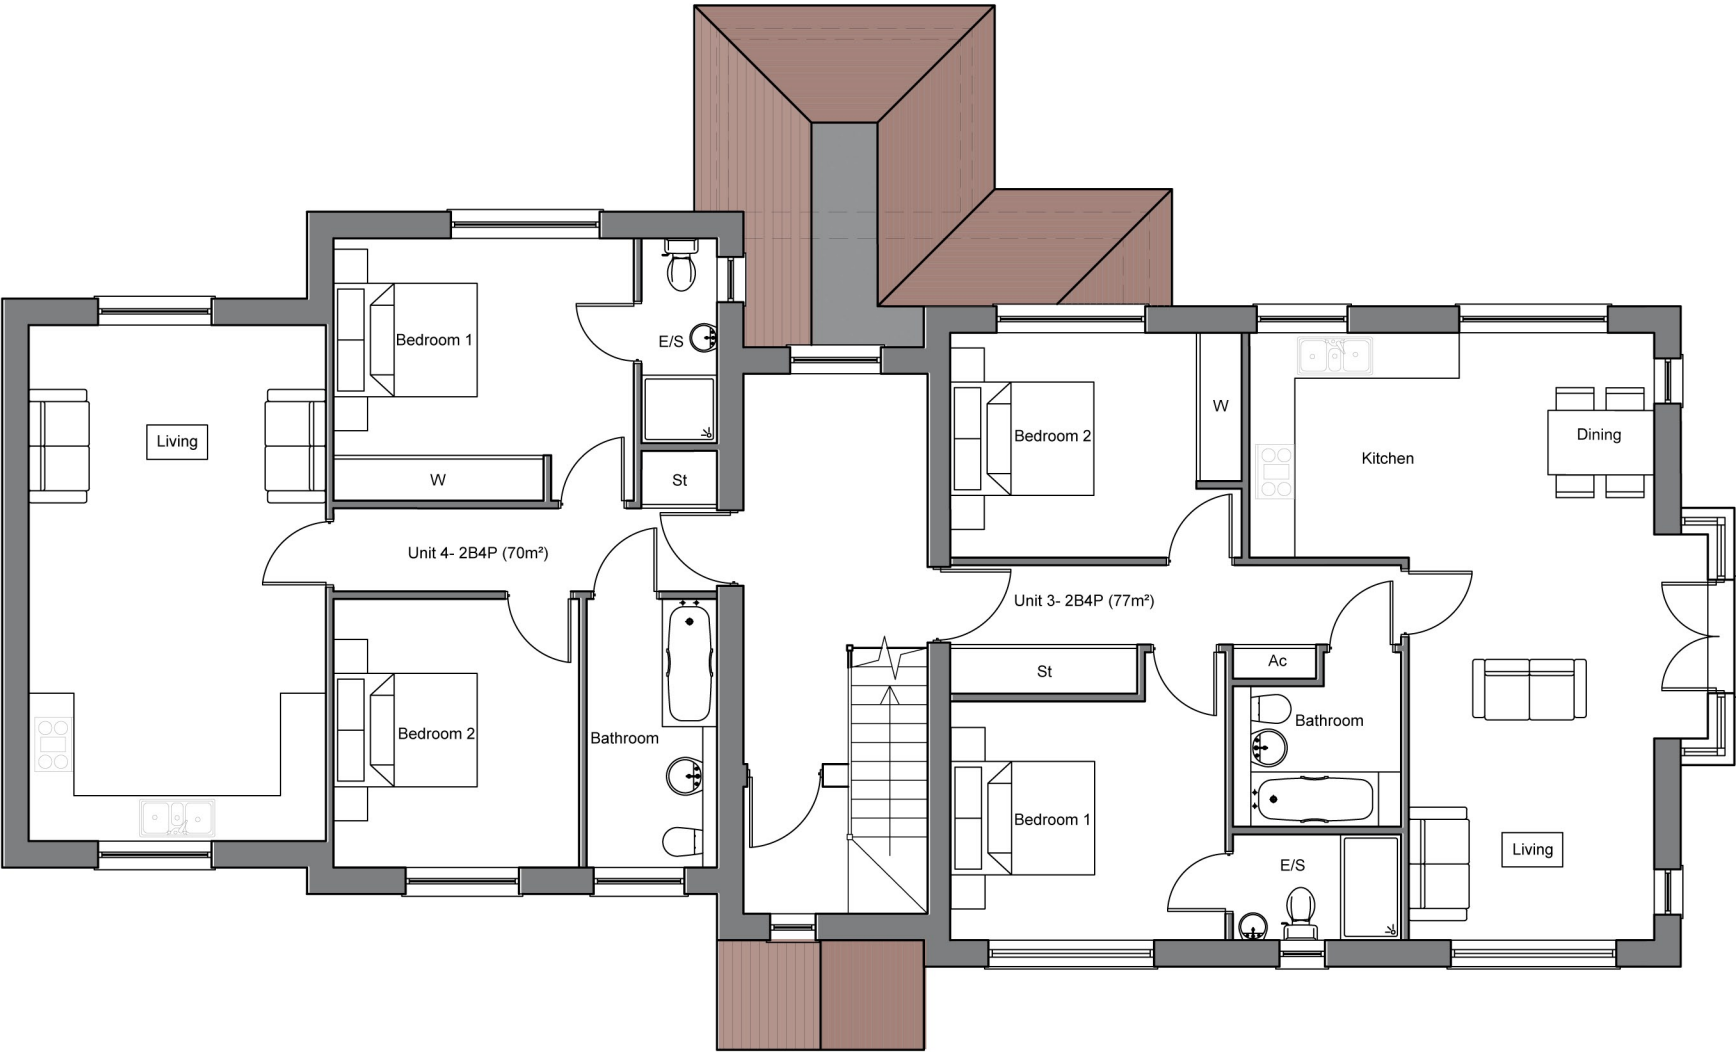

First Floor Plan

**REVISIONS:**

Rev	Date	Description	By
A	21/08/24	Proposed footprint reduced	CC

**PROJECT STAGE:** PLANNING

**CLIENT:**  
Fox Homes Ltd

**PROJECT & DRAWING TITLE:**  
134 Carbery Avenue, Bournemouth

Proposed Plans

**Scale @ A3:** 1:100 **Drawn by:** CC  
**Date:** 20/11/23

<b>DRAWING No:</b> ASP.23.056.P101	<b>REVISION:</b> A
---------------------------------------	-----------------------

**ARCHITECTURE - PLANNING - PROJECT MANAGEMENT - CDM**

74 Sopers Lane  
Christchurch,  
BH23 1JF  
01202 473222  
[www.aspirearchitects.co.uk](http://www.aspirearchitects.co.uk)  
[info@aspirearchitects.co.uk](mailto:info@aspirearchitects.co.uk)  
© Aspire Architects Ltd

